

DRAWING INDEX

CODE ANALYSIS AND ABBREVIATIONS

ACQUEDOTTI ELLIOTT INC.

[illegible]

2. UNLESS OTHERWISE NOTED, DOWNGRADING IS TO FACE OF STUD AND TO FACE OF STRUCTURAL PANELS.

— SALT CRISTAL SECTION NUMBER

— DETAIL NUMBER




INTERNATIONAL BUILDING CODE IS ENFORCED BY THE STATE OF MISSISSIPPI
AND THE CITY OF JACKSON.
THE CODE IS APPLICABLE TO THE CITY OF JACKSON.

ACCOMPLISHMENTS

DATE AND MONDAY 41: CHAPTER 9 FCC THE R-1 OCCUPANCY IS AN ACCESSORY USE AREA TO THE R OCCUPANCY. PARAGRAPHS ARE NOT INVOLVED WITH THE R-1 OCCUPANCY.

RECEIVED

1

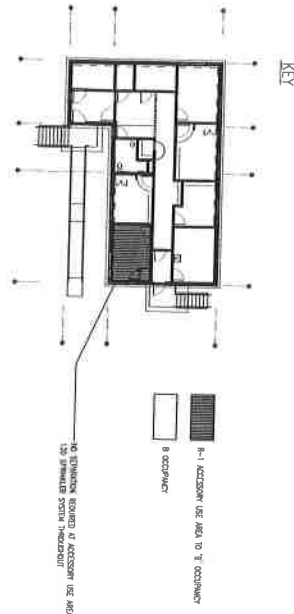

CHECKED BY: _____
REVISIONS: _____
RR _____
- _____

DRAWING INDEX
GENERAL NOTES
CODE ANALYSIS


T11

W WATTERSON CONSTRUCTION
ph: (907)563-7441 fax: (907)563-7222

BETTISWORTH NORTH
ARCHITECTS AND PLANNERS



BETTISWORTH ANCHORAGE, ALASKA 99503 907 561-3780
ONE PROSPECT STREET FAIRBANKS, ALASKA 99701 907 458-5718

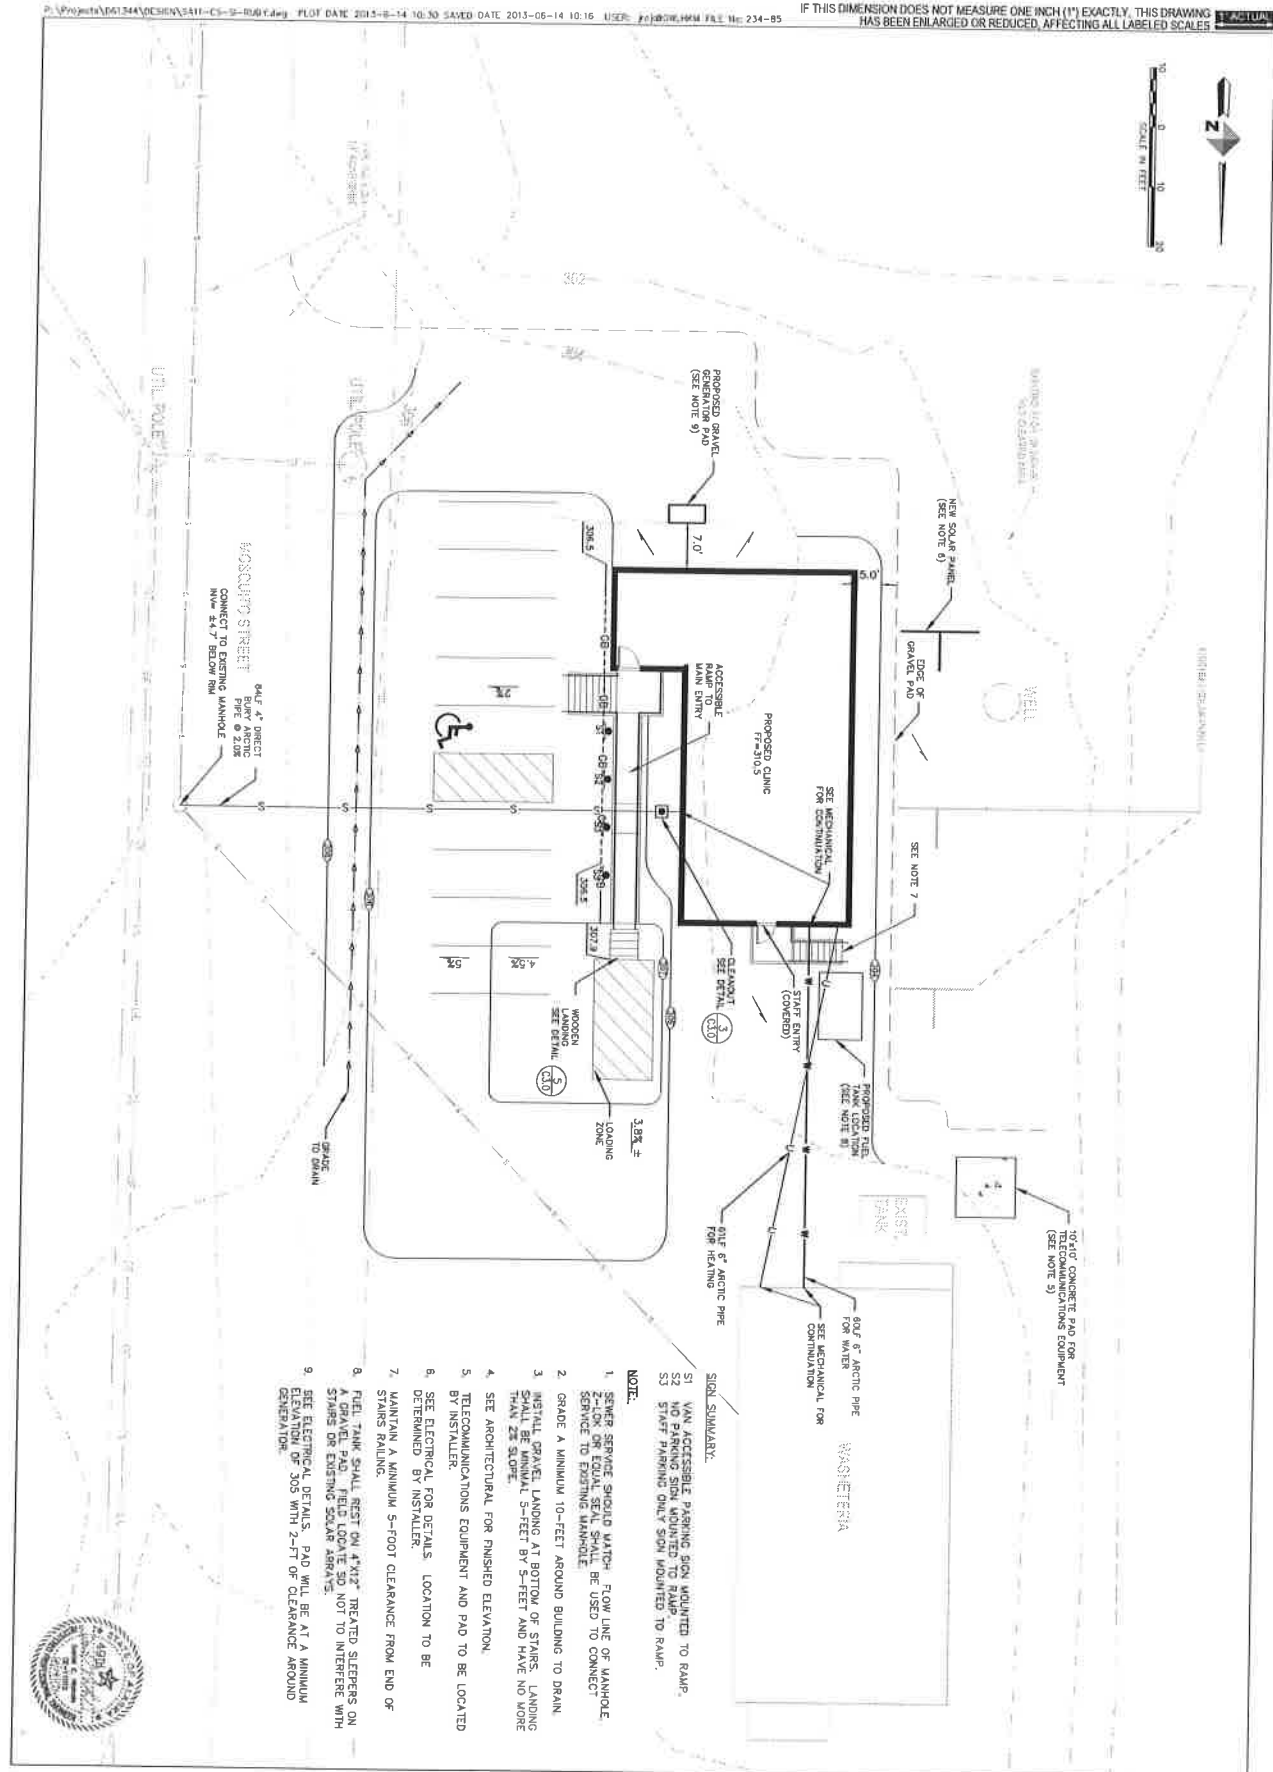

C1.0

PROJECT NO: 12-15
DATE: 14 JUNE 2014
DRAWN BY: J
CHECKED BY: DE
REVISIONS:


DOWL HKM

100% CONSTRUCTION DRAWINGS

12-152
TANANA CHIEFS CONFERENCE
RUBY CLINIC
RUBY, ALASKA

W WATTERSON CONSTRUCTION
 ph: (907)563-7441 fax: (907)563-7222
BETTISWORTH NORTH
 ARCHITECTS AND PLANNERS

2600 DENALI STREET SUITE 730 ANCHORAGE, ALASKA 99503 907 561-5789
222 FRONT STREET FAIRBANKS, ALASKA 99701 907 458-5784
WWW.BETTISWORTH1011.COM

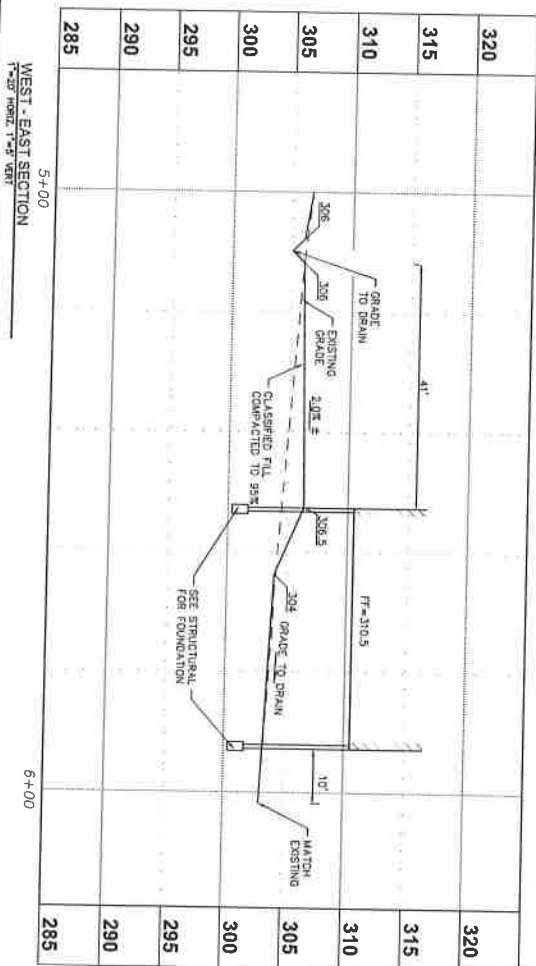

NOTES:

1. EXISTING BUILDING PAD IS GRAVEL. REMOVE ALL SURFACES ORGANICS AND ADD COMPACTED CLASSIFIED FILL TO MATCH GRADING.
2. CLASSIFIED FILL IS COMPACTIBLE, NON-FROST SUSCEPTIBLE GRAVEL FREE OF DEBRIS, ORGANICS, AND 3-INCH OR LARGER ROCKS.



C2.0

PROJECT NO: 12-152
DATE: 14 JUNE 2013
DRAWN BY: JR
CHECKED BY: DEN
REVISIONS:



DOWL HKM
4011 B Street
San Jose, CA 95128
Tel: 408.261.1000
Fax: 408.261.1001
www.dowlhkm.com

100% CONSTRUCTION DRAWINGS


12-152
TANANA CHIEFS CONFERENCE
RUBY CLINIC

RUBY, ALASKA

WATTERSON CONSTRUCTION

BETTISWORTH^{NORTH}
ARCHITECTS AND PLANNERS

2600 DENALI STREET SUITE 710 ANCHORAGE, ALASKA 99503 907-561-0780
212 FRONT STREET FAIRMANKS, ALASKA 99701 907-456-3700
WWW.BETTESWORTHNORTH.COM

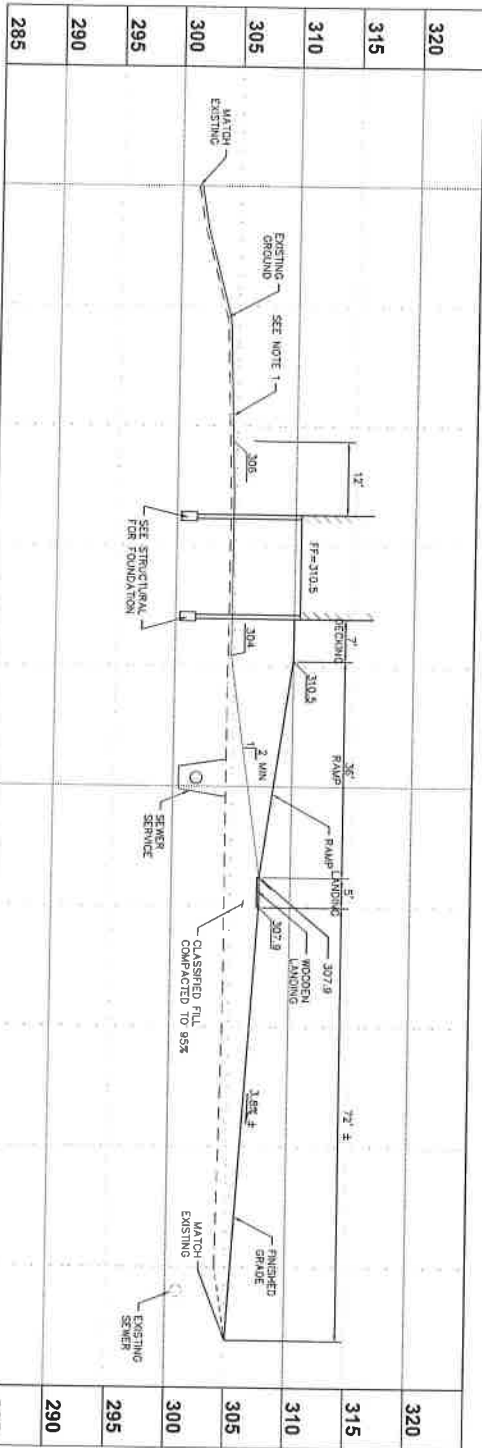

- NOTES:
1. EXISTING BUILDING PAD IS GRAVEL. REMOVE ALL SURFACES ORGANICS AND ADD COMPACTED CLASSIFIED FILL TO MATCH GRADING.
 2. RAMP SHALL HAVE A MAXIMUM SLOPE OF 8.3% SEE ARCHITECTURAL FOR DETAILS.
 3. CLASSIFIED FILL IS COMPACTIBLE NON-FROST SUSCEPTIBLE GRAVEL FREE OF DEBRIS, ORGANICS, AND 3-INCH OR LARGER ROCKS.

SOUTH - NORTH SECTION

1+00

2+00

3+00




C2.1

PROJECT NO.: 12-152
DATE: 14 JUNE 2013
DRAWN BY: JR
CHECKED BY: DEN
REVISIONS:




100% CONSTRUCTION DRAWINGS
12-152
TANANA CHIEFS CONFERENCE
RUBY CLINIC
RUBY, ALASKA

WATTERSON CONSTRUCTION
PH: (907)563-2441 FAX: (907)563-7222
BETTISWORTH NORTH
ARCHITECTS AND PLANNERS
2600 DENALI STREET SUITE 7TH ANCHORAGE, ALASKA 99503 907 561-3788
314 PRIME STREET FAIRBANKS, ALASKA 99701 907 438-2794
WWW.BETTISWORTHNORTH.COM

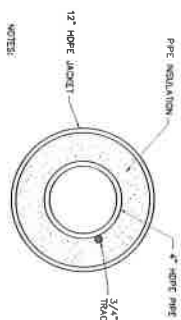


1. 4-INCH HOPE SHALL HAVE A MAXIMUM SDR OF 21.0 AND A MINIMUM PRESSING RATING OF 64 PSI. THE 12-INCH HOPE JACKET SHALL HAVE A SDR OF 32.5.
2. PIPE INSULATION SHALL BE POLYURETHANE FOAMED SEAL AND A MINIMUM DENSITY OF 2.0 LB./CUBIC FOOT. THE INSULATION SHALL HAVE AN INITIAL THERMAL CONDUCTIVITY FACTOR (K) OF NOT GREATER THAN 0.012 BTU-INCHES/FOOT-SQUARE FOOT-DEGREE.

ARCTIC SEWER PIPE DETAIL

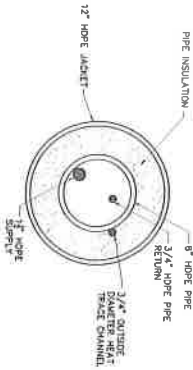


- [illegible]

ARCTIC WATER PIPE DETAIL

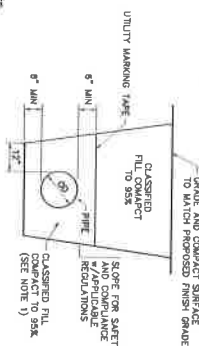


- [illegible]

2 TYPICAL UTILITY TRENCH SECTIONS
C3.0 NTS

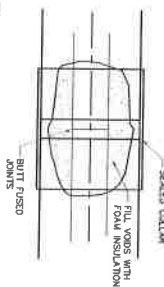


- NOTES:
1. ALL HDPE CARRIER JOINTS SHALL BE HEAT FUSED BUTT JOINTS.
 2. ALL HDPE JACKET JOINTS SHALL BE HEAT SHRINK SEALS.

TYPICAL HDPE PIPE JACKET JOINT

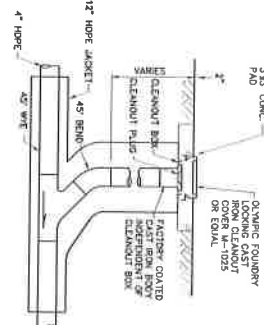

- 3
C3.0
- SEWER SERVICE CONNECTION & CLEANOUT
- M.T.S.

 SEWER SERVICE CONNECTION & CLEANOUT




1. LANDING SHALL BE 5-FOOT.
2. ALL WOOD SHALL BE ALL-WEATHER TREATED LUMBER.
3. THERE SHALL NOT BE A SPACE GAP GREATER THAN 1/8-INCH BETWEEN DECKING.
4. SECURE DECKING WITH 2-INCH WOOD SCREWS AT EACH SLEEPER. SCREWS HEADS SHALL BE COUNTER SUNKEN BELOW SURFACE.
5. DECKING SHALL BE SMOOTH WITHOUT TRIPPING HAZARD.

WOOD LANDING



FLOOR PLAN
1/4"=1'-0"

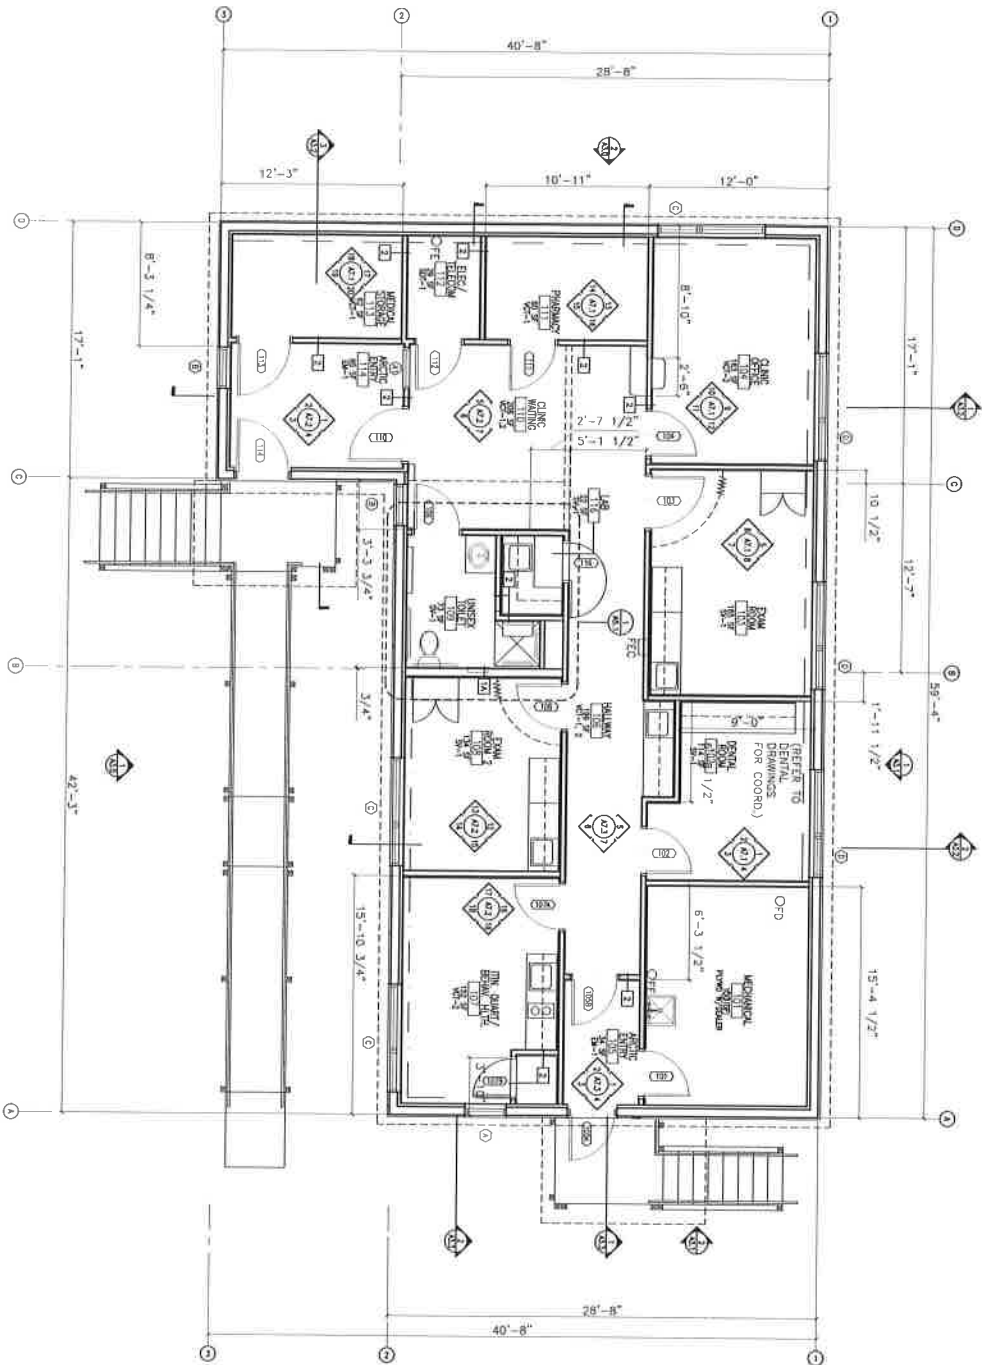

PLAN NOTES:

- [illegible]

NOT FOR CONSTRUCTION

A1.1

FLOOR PLAN

CONSULTANT

95% DRAWINGS: NOT FOR CONSTRUCTION

12-152
TANANA CHIEFS CONFERENCE
RUBY CLINIC
RUBY, ALASKA



WATTERSON CONSTRUCTION
ph: (907)563-7441 fax: (907)563-7222


BETTISWORTH NORTH
ARCHITECTS AND PLANNERS

2600 DENALI STREET SUITE 710 ANCHORAGE, ALASKA 99503 907 561-5780
212 FRONT STREET FAIRBANKS, ALASKA 99701 907 456-5780
WWW.BETTISWORTHNORTH.COM

IF THIS DIMENSION DOES NOT MEASURE ONE INCH (1") EXACTLY, THIS DRAWING
HAS BEEN ENLARGED OR REDUCED, AFFECTING ALL LABELED SCALES

REFLECTED CEILING PLAN

1/4"=1'-0"

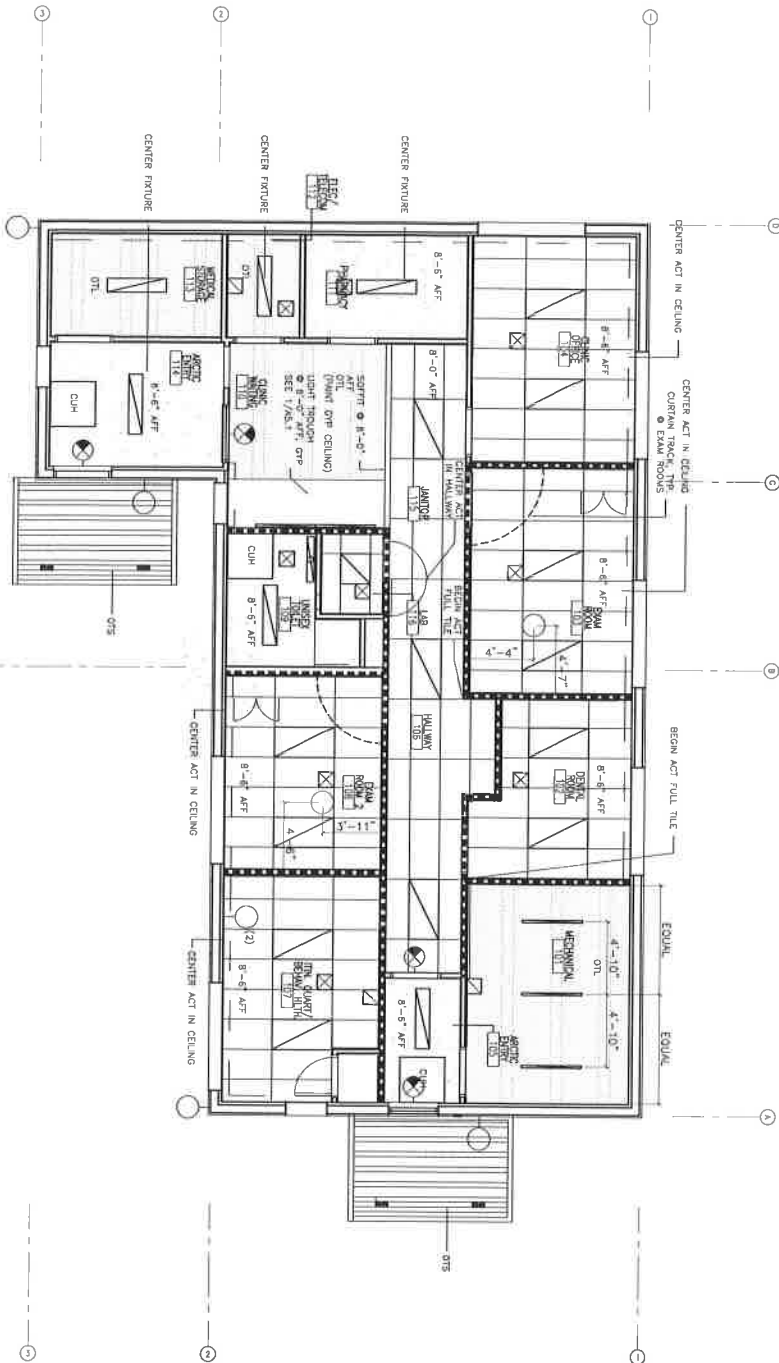

REFLECTED CEILING PLAN SYMBOL KEY

- 24\"/>

GENERAL NOTES

- COORDINATE SHOWN DETECTION, INSULATION AND LEAKS WITH ELECTRICAL DRAWINGS.
- SEE ELECTRICAL AND MECHANICAL FOR ADDITIONAL CEILING MOUNTED ITEMS.
- SEE MECHANICAL FOR SCHEDULING (SCHED) AND (S) FOR ALL CEILING ITEMS.
- VERIFY REFLECTED CEILING TO BE COMPLETED WITH (1) LAYERS OF 5/8\"/>

NOT FOR CONSTRUCTION

PROJECT NO: 12-152
DATE: 10 MAY 2013
DRAWN BY: MS, JIS
CHECKED BY: RR
REVISIONS:

95% DRAWINGS: NOT FOR CONSTRUCTION


12-152
TANANA CHIEFS CONFERENCE
RUBY CLINIC
RUBY, ALASKA




WATERSON CONSTRUCTION
PH: (907)563-7441 FAX: (907)563-7222

BETTISWORTH NORTH
ARCHITECTS AND PLANNERS

2600 DENALI STREET SUITE 710 ANCHORAGE, ALASKA 99503 907.561-5780
212 FRONT STREET FAIRBANKS, ALASKA 99701 907.456-5780
WWW.BETTISWORTHNORTH.COM

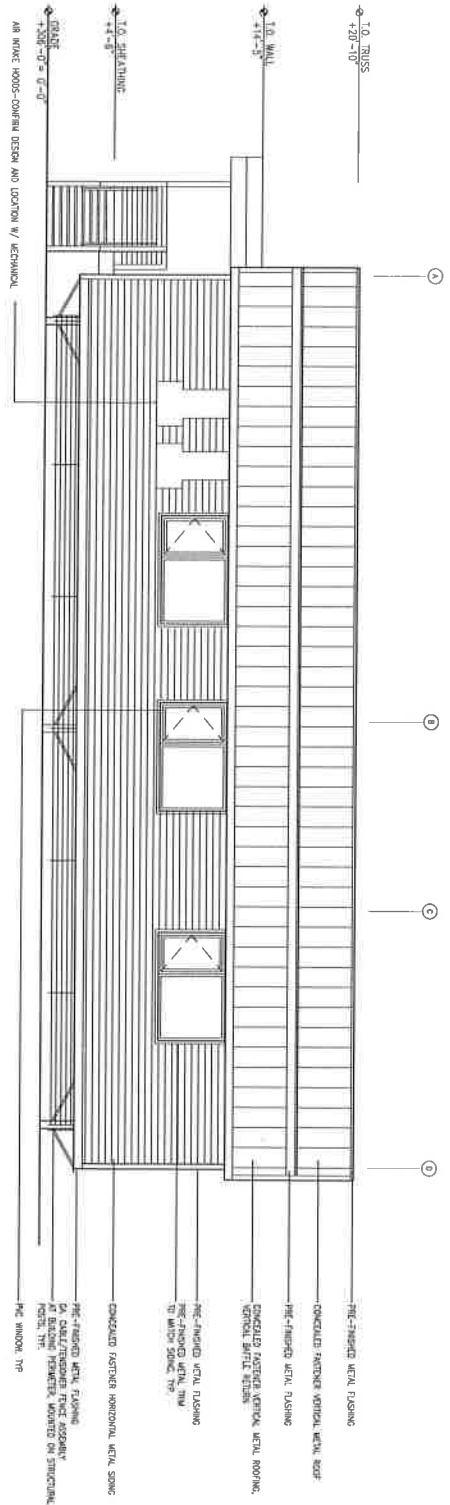

1
WEST ELEVATION
1/4"=1'-0"

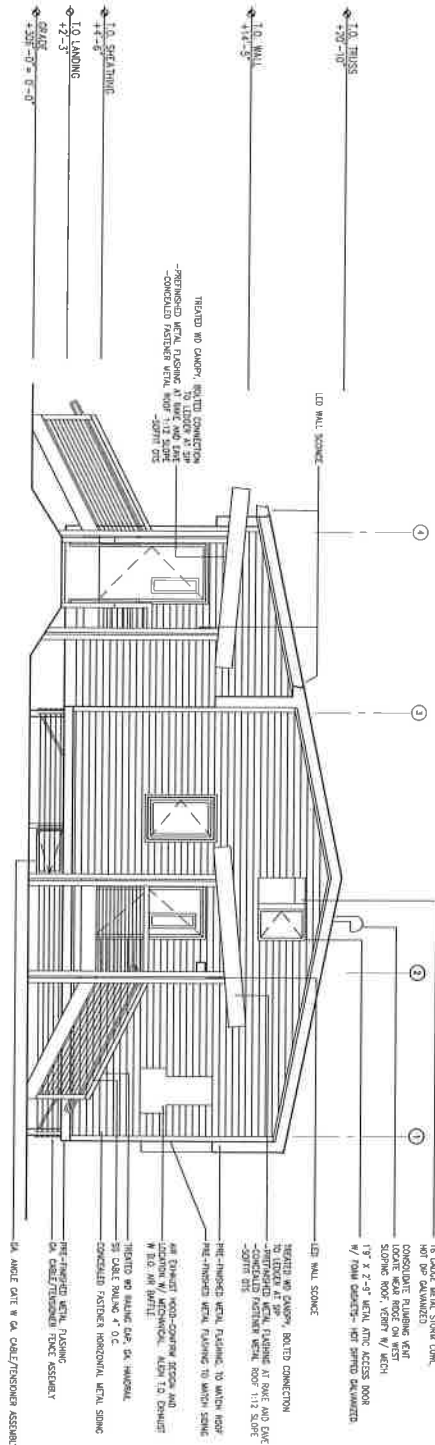

2
NORTH ELEVATION
1/4"=1'-0"

NOT FOR CONSTRUCTION

A3.1

EXTERIOR
ELEVATIONS

PROJECT NO: 12-152
DATE: 10 MAY 2013
DRAWN BY: MC JS
CHECKED BY: RR
REVISIONS:


95% DRAWINGS: NOT FOR CONSTRUCTION

12-152
TANANA CHIEFS CONFERENCE
RUBY CLINIC
RUBY, ALASKA




WATTERSON CONSTRUCTION
ph: (907)563-7441 fax: (907)563-7222
BETTISWORTH NORTH
ARCHITECTS AND PLANNERS
2600 DENALI STREET SUITE 710 ANCHORAGE, ALASKA 99503 907.561-5780
212 FRONT STREET FAIRBANKS, ALASKA 99701 907.456-5780
WWW.BETTISWORTHNORTH.COM


IF THIS DIMENSION DOES NOT MEASURE ONE INCH (1") EXACTLY, THIS DRAWING
HAS BEEN ENLARGED OR REDUCED, AFFECTING ALL LABELED SCALES

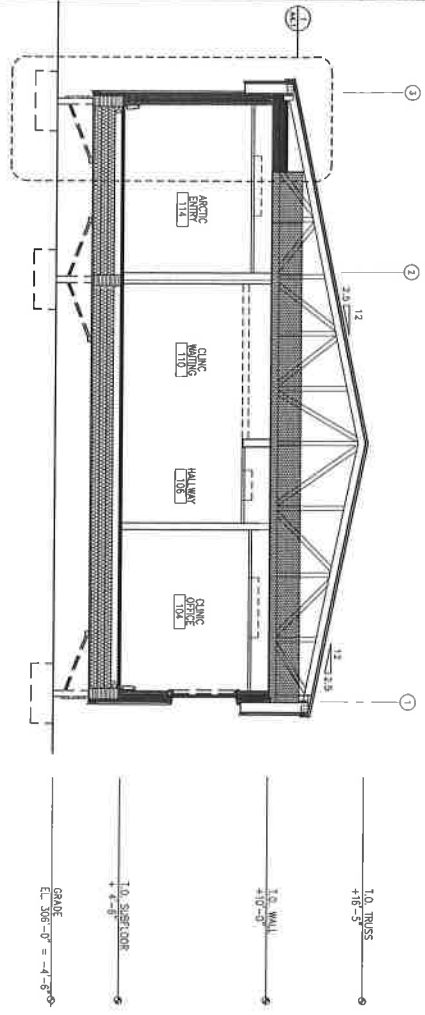

1
A3.2
1/4"=1'-0"

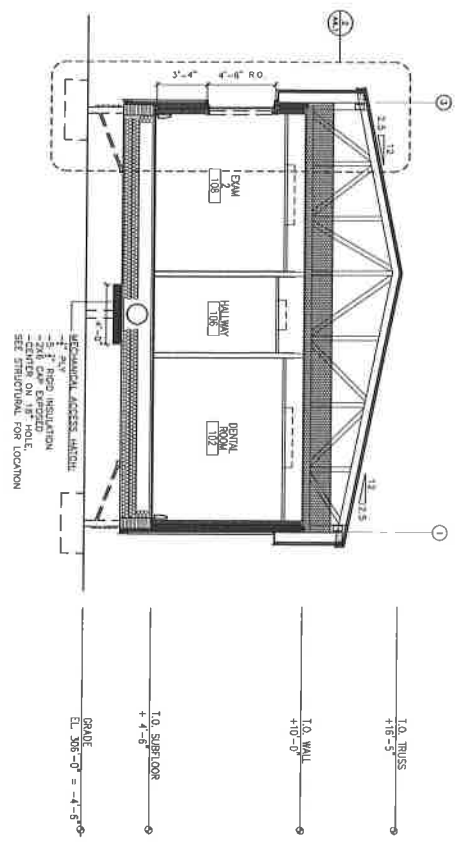

2
A3.2
1/4"=1'-0"

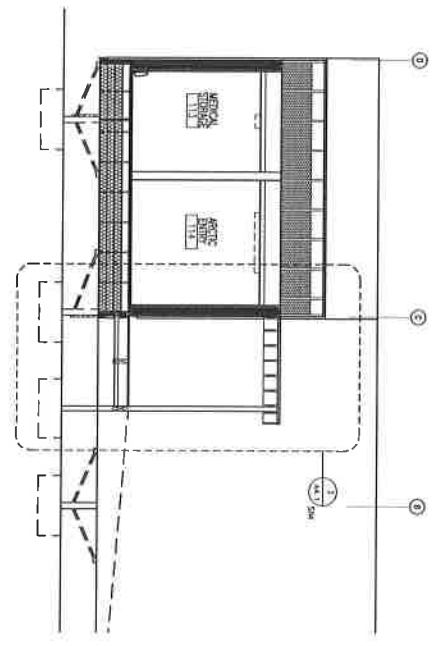

3
A3.2
1/4"=1'-0"

NOT FOR CONSTRUCTION

BUILDING SECTIONS A3.2	PROJECT NO:	13-182
	DATE:	10 MAY 2013
	DRAWN BY:	M.G. JS
	CHECKED BY:	PR

95% DRAWINGS: NOT FOR CONSTRUCTION

12-152
TANANA CHIEFS CONFERENCE
RUBY CLINIC
RUBY, ALASKA




WATTERSON CONSTRUCTION
ph: (907)563-7441 fax: (907)563-7222


BETTISWORTH NORTH
ARCHITECTS AND PLANNERS

2600 DENALI STREET SUITE 710 ANCHORAGE, ALASKA 99503 907.561.5786
212 FRONT STREET FAIRBANKS, ALASKA 99701 907.456-5780
WWW.BETTISWORTHNORTH.COM

BUILDING SECTION
1/2"=1'-0"

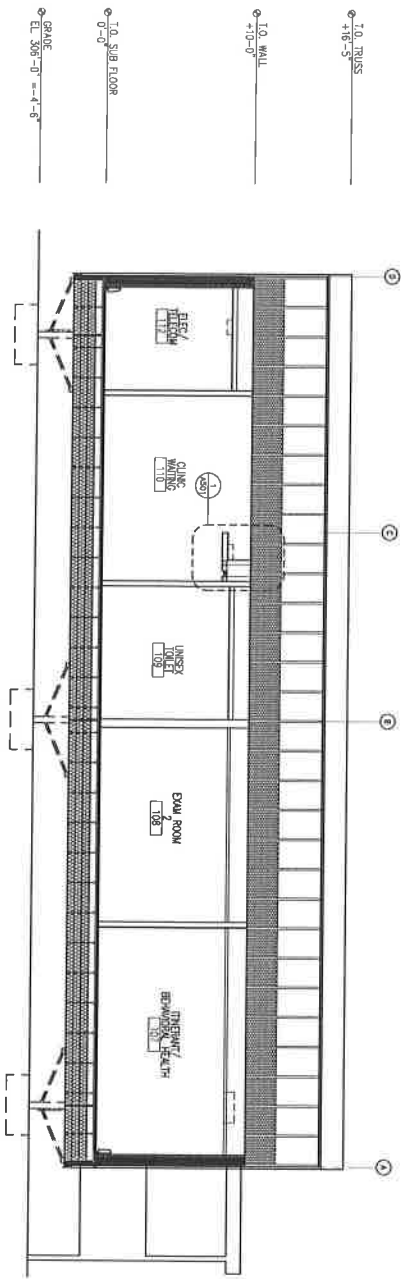

BUILDING SECTION
1/2"=1'-0"

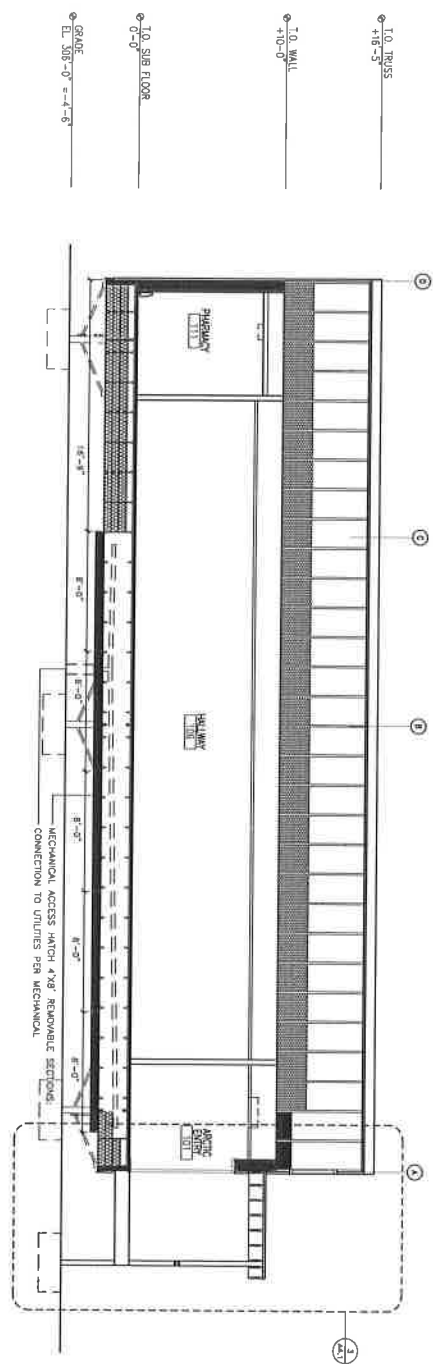

NOT FOR CONSTRUCTION

BUILDING SECTIONS
A3.3

PROJECT NO: 12-152
DATE: 10 MAY 2013
DRAWN BY: MG, JS
CHECKED BY: RR
REVISIONS:

CONSULTANT

12-152
TANANA CHIEFS CONFERENCE
RUBY CLINIC
RUBY, ALASKA

95% DRAWINGS: NOT FOR CONSTRUCTION




WATTERSON CONSTRUCTION
ph: (907)563-7441 fax: (907)563-7222

BETTISWORTH NORTH
ARCHITECTS AND PLANNERS


2000 DENALI STREET SUITE 710 ANCHORAGE, ALASKA 99503 907.561.9780
212 FRONT STREET FAIRBANKS, ALASKA 99701 907.456-5780
WWW.BETTISWORTHNORTH.COM

IF THIS DIMENSION DOES NOT MEASURE ONE INCH (1") EXACTLY, THIS DRAWING HAS BEEN ENLARGED OR REDUCED, AFFECTING ALL LABELED SCALES


1 WALL SECTION
1/2"=1'-0"

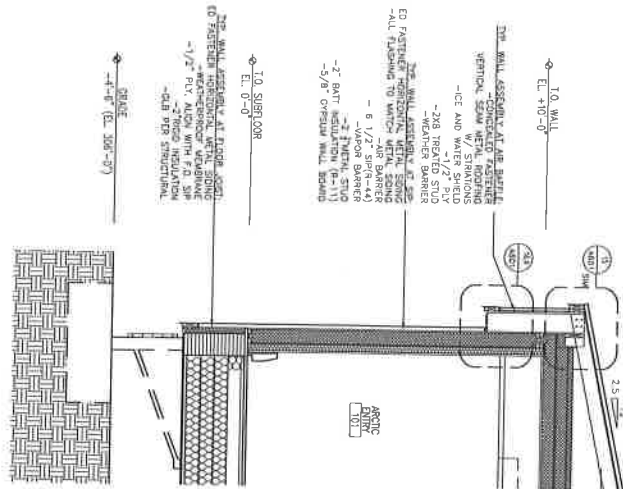

2 WALL SECTION
1/2"=1'-0"

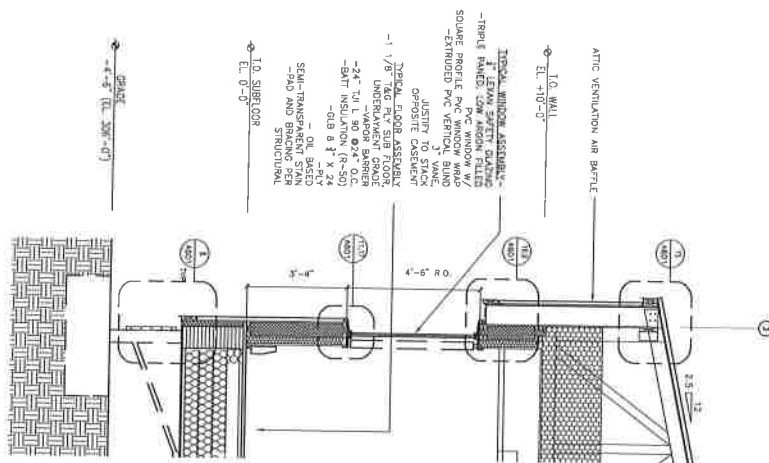

3 WALL SECTION
1/2"=1'-0"

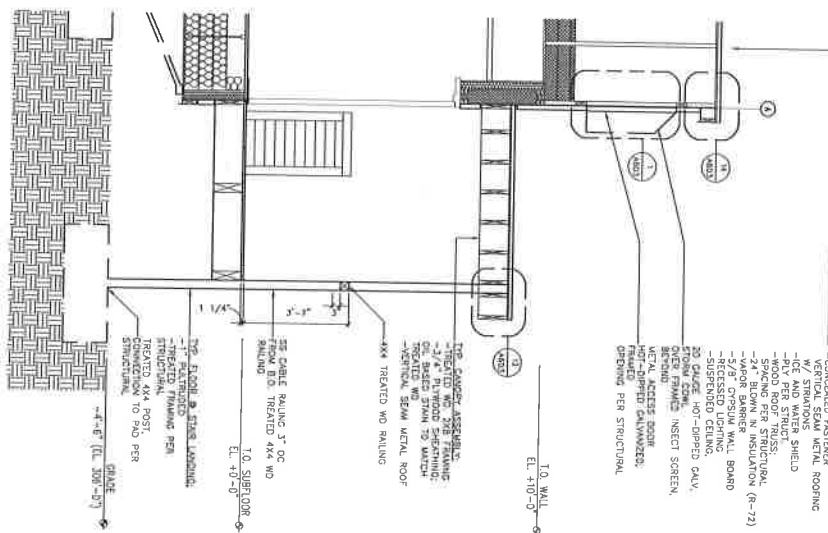

NOT FOR CONSTRUCTION

PROJECT NO:	12-152
DATE:	10 MAY 2013
DRAWN BY:	MG, JS
CHECKED BY:	RR
REVISIONS:	

WALL SECTIONS
A4.1

95% DRAWINGS; NOT FOR CONSTRUCTION

12-152
TANANA CHIEFS CONFERENCE
RUBY CLINIC
RUBY, ALASKA



WATTERSON CONSTRUCTION
ph: (907)563-7441 fax: (907)563-7222
BETTISWORTH NORTH
ARCHITECTS AND PLANNERS
2600 DENALI STREET SUITE 710 ANCHORAGE, ALASKA 99503 907.561.5788
212 FRONT STREET FAIRBANKS, ALASKA 99701 907.438.5588
WWW.BETTISWORTHNORTH.COM




9/19/12 Date Rec'd: 12/13-2012
6/14/2012 to 27 42




IF THIS DIMENSION DOES NOT MEASURE ONE INCH (1") EXACTLY, THIS DRAWING
HAS BEEN ENLARGED OR REDUCED, AFFECTING ALL LABELED SCALES

1" ACTUAL


1
A5.3
1/2"=1'-0"
ENLARGED LANDING PLAN

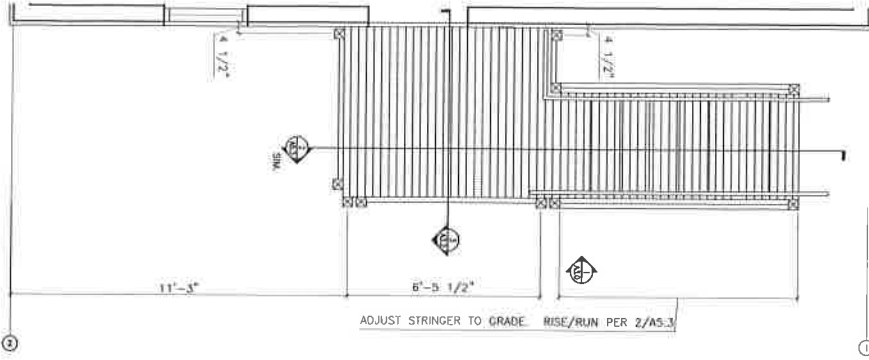

3
A5.3
1/2"=1'-0"
RAMP SECTION

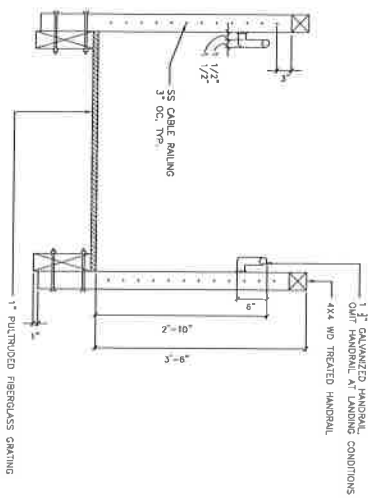

2
A5.3
1/2"=1'-0"
STAIR/LANDING SECTION

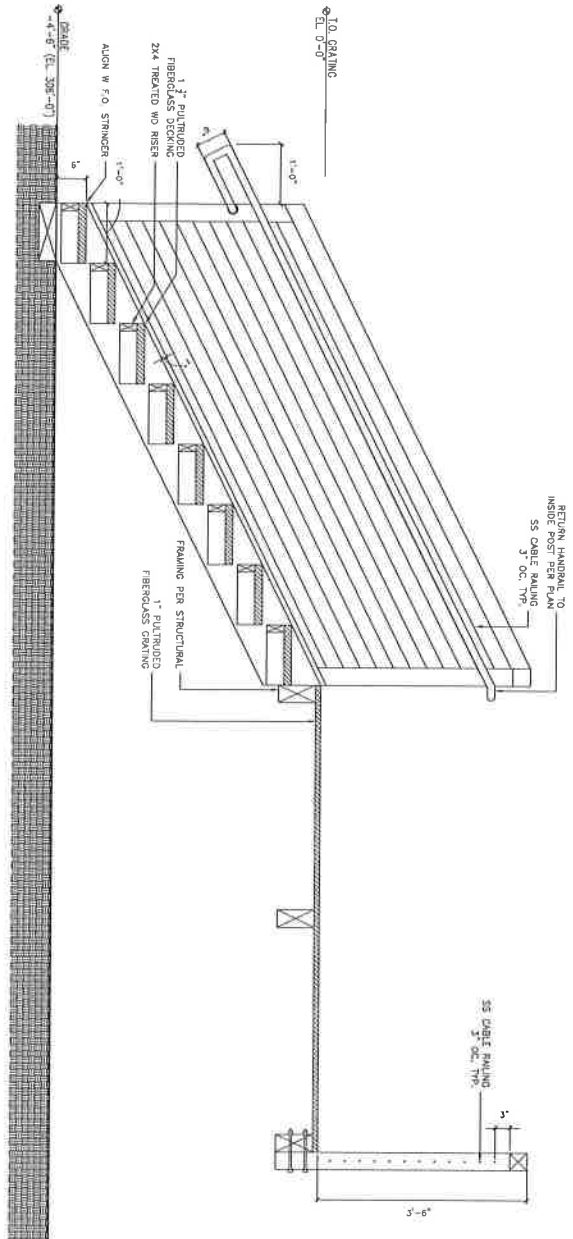

NOT FOR CONSTRUCTION

PROJECT NO. 12-152	DATE 10/1/13
	DRAWN BY: MC JS
	CHECKED BY: MC JS
	REVISIONS:

RAMP/STAIR
DETAILS
A5.3


95% DRAWINGS: NOT FOR CONSTRUCTION

12-152
TANANA CHIEFS CONFERENCE
RUBY CLINIC
RUBY, ALASKA




WATTERSON CONSTRUCTION
PH: (907) 563-7441 FAX: (907) 563-7222
BETTISWORTH NORTH
ARCHITECTS AND PLANNERS


2000 DENALI STREET SUITE 710 ANCHORAGE, ALASKA 99503 907 561-5780
212 FRONT STREET FAIRBANKS, ALASKA 99701 907 456-5780
WWW.BETTISWORTHNORTH.COM

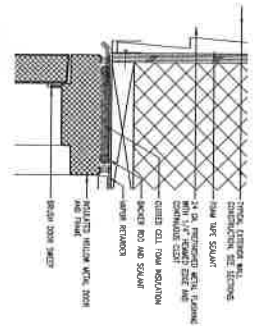


5 EXTERIOR DOOR HEAD
3"=1'-0"

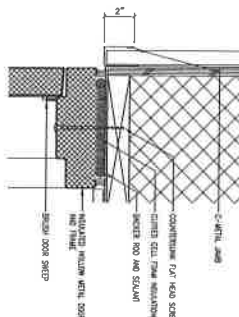


6 EXTERIOR DOOR JAMB
3"=1'-0"

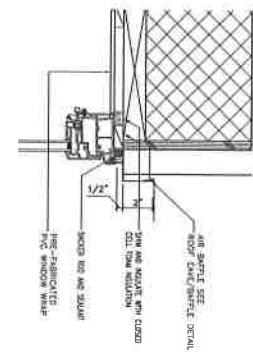


9 WINDOW HEAD
3"=1'-0"

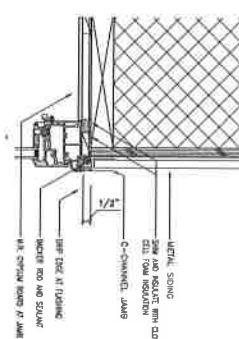


10 WINDOW JAMB
3"=1'-0"

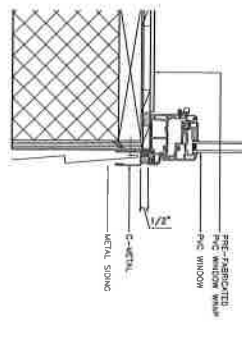


11 WINDOW SILL
3"=1'-0"

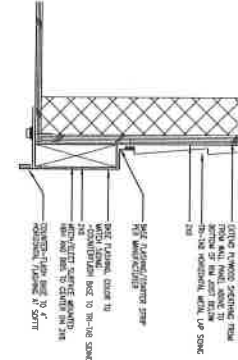


8 BASE FLASHING
3"=1'-0"

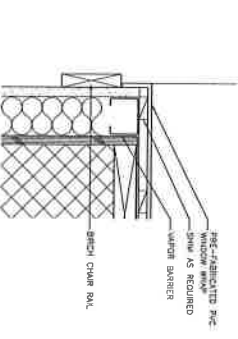


12 WINDOW SILL
3"=1'-0"

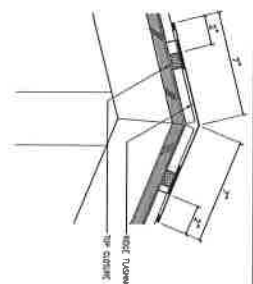


13 RIDGE CAP
3"=1'-0"

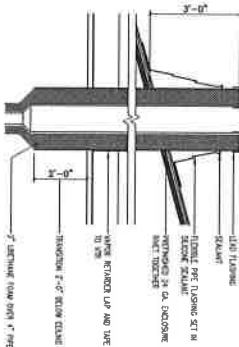

14 VENT THROUGH ROOF
1 1/2"=1'-0"

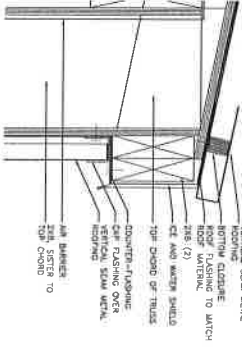

15 2.5:12 ROOF EAVE
3"=1'-0"

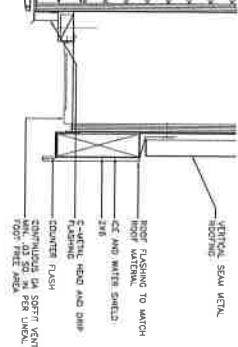

16 ROOF EAVE/BAFFLE
3"=1'-0"

NOT FOR CONSTRUCTION

EXTERIOR
DETAILS
A6.1

PROJECT NO.: 12-152
DATE: 10 MAY 2013
DRAWN BY: M.G.J.S.
CHECKED BY: RR
REVISIONS:

95% DRAWINGS: NOT FOR CONSTRUCTION
CONSULTANT:
12-152
TANANA CHIEFS CONFERENCE
RUBY CLINIC
RUBY, ALASKA




WATTERSON CONSTRUCTION
ph: (907)563-7441 fax: (907)563-7222
BETTISWORTH NORTH
ARCHITECTS AND PLANNERS
2600 DENALI STREET SUITE 710 ANCHORAGE, ALASKA 99503 907-561-5780
312 FRONT STREET FAIRBANKS, ALASKA 99701 907-456-5880
WWW.BETTISWORTHNORTH.COM

IF THIS DIMENSION DOES NOT MEASURE ONE INCH (1") EXACTLY, THIS DRAWING HAS BEEN ENLARGED OR REDUCED, AFFECTING ALL LABELED SCALES

2 WINDOW WATERPROOFING ASSEMBLY


NOTE: 1/2" AT RAKE OF CURB, 1/2" AT WEATHERED CORNER, 1/2" AT SILL, 1/2" AT HEAD

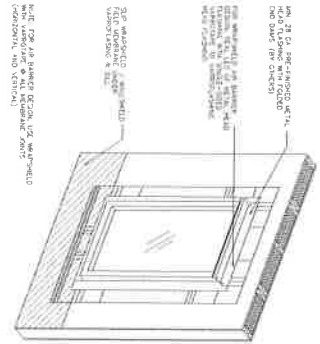

DETAIL 2

3 WINDOW WATERPROOFING ASSEMBLY


NOTE: 1/2" AT RAKE OF CURB, 1/2" AT WEATHERED CORNER, 1/2" AT SILL, 1/2" AT HEAD

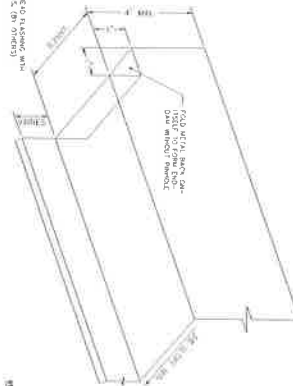

DETAIL 3

4 WINDOW WATERPROOFING ASSEMBLY


NOTE: 1/2" AT RAKE OF CURB, 1/2" AT WEATHERED CORNER, 1/2" AT SILL, 1/2" AT HEAD

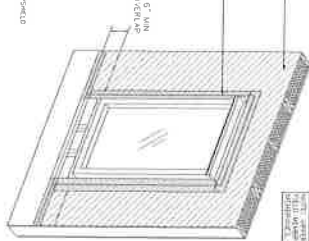

DETAIL 4

5 WINDOW WATERPROOFING ASSEMBLY


NOTE: 1/2" AT RAKE OF CURB, 1/2" AT WEATHERED CORNER, 1/2" AT SILL, 1/2" AT HEAD

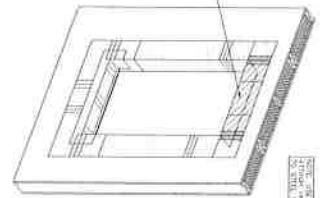

DETAIL 5

6 WINDOW WATERPROOFING ASSEMBLY


NOTE: 1/2" AT RAKE OF CURB, 1/2" AT WEATHERED CORNER, 1/2" AT SILL, 1/2" AT HEAD

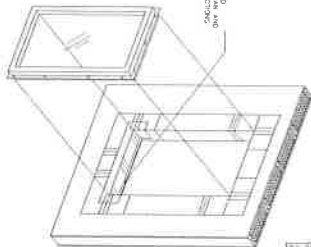

DETAIL 6

7 WINDOW WATERPROOFING ASSEMBLY


NOTE: 1/2" AT RAKE OF CURB, 1/2" AT WEATHERED CORNER, 1/2" AT SILL, 1/2" AT HEAD

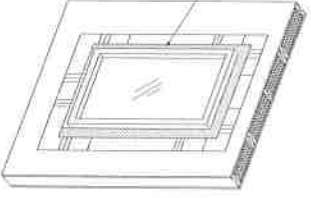

DETAIL 7

8 WINDOW WATERPROOFING ASSEMBLY


NOTE: 1/2" AT RAKE OF CURB, 1/2" AT WEATHERED CORNER, 1/2" AT SILL, 1/2" AT HEAD

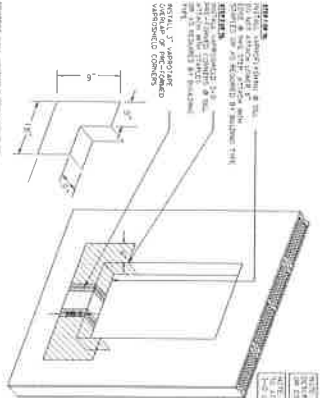

DETAIL 8

9 WINDOW WATERPROOFING ASSEMBLY


NOTE: 1/2" AT RAKE OF CURB, 1/2" AT WEATHERED CORNER, 1/2" AT SILL, 1/2" AT HEAD

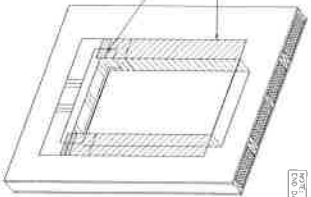

DETAIL 9

10 WINDOW WATERPROOFING ASSEMBLY

NOTE: 1/2" AT RAKE OF CURB, 1/2" AT WEATHERED CORNER, 1/2" AT SILL, 1/2" AT HEAD

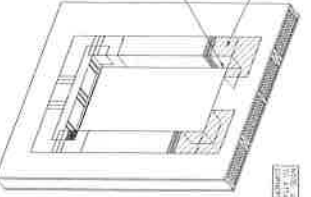

DETAIL 10

NOT FOR CONSTRUCTION

PROJECT NO.	12-152
DATE	10 MAY 2013
DRAWN BY	MS/JS
CHECKED BY	NR
REVISIONS	
EXTERIOR DETAILS	A6.2

95% DRAWINGS: NOT FOR CONSTRUCTION

12-152
TANANA CHIEFS CONFERENCE
RUBY CLINIC
RUBY, ALASKA




WATERSON CONSTRUCTION
BETTISWORTH NORTH
ARCHITECTS AND PLANNERS

2600 DENALI STREET SUITE 710 ANCHORAGE, ALASKA 99503 907 561-5780
212 FRONT STREET FAIRBANKS, ALASKA 99701 907 456-5780
WWW.BETTISWORTHNORTH.COM


IF THIS DIMENSION DOES NOT MEASURE ONE INCH (1") EXACTLY, THIS DRAWING
HAS BEEN ENLARGED OR REDUCED, AFFECTING ALL LABELED SCALES

1 ACTUAL

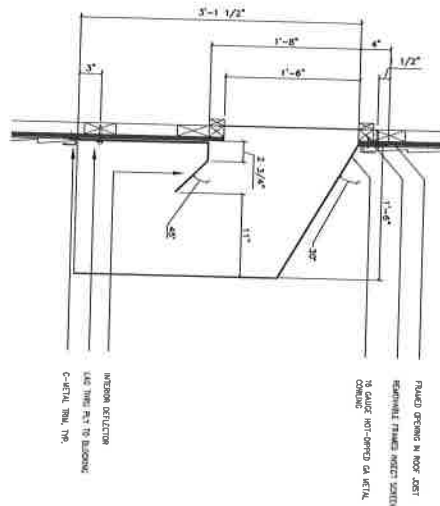


1
A6.3 1 1/2"=1'-0"

COWLING SECTION

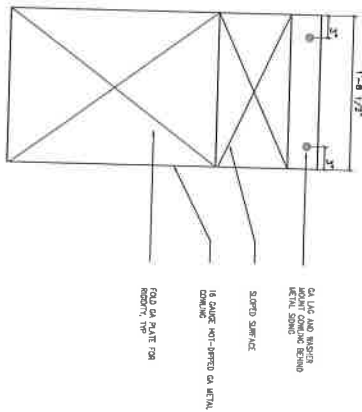


2
A6.3 1 1/2"=1'-0"

COWLING ELEVATION

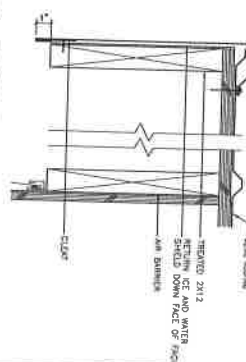

14
A6.3 3"=1'-0"

RAKE DETAIL

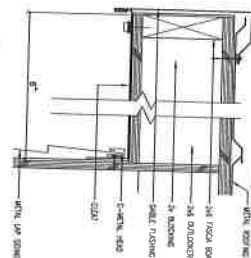

13
A6.3 3"=1'-0"

RAKE DETAIL

NOT FOR CONSTRUCTION

EXTERIOR DETAILS	PROJECT NO:	12-152
	DATE:	10 MAY 2013
	DRAWN BY:	M.G. JS
	CHECKED BY:	NR
	REVISIONS:	NR

A6.3

95% DRAWINGS: NOT FOR CONSTRUCTION

12-152
TANANA CHIEFS CONFERENCE
RUBY CLINIC
RUBY, ALASKA




WATTERSON CONSTRUCTION
ph: (907)563-7441 fax: (907)563-7222


BETTISWORTH NORTH
ARCHITECTS AND PLANNERS

2500 BRIDGEMAN STREET SUITE 714 ANCHORAGE, ALASKA 99503 907 564-2784
212 FRONT STREET FAIRBANKS, ALASKA 99701 907 434-5154
WWW.BETTISWORTHNORTH.COM


PROJECT NO:	12-15
DATE:	10 MAY 2011
DRAWN BY:	MG, JS
CHECKED BY:	RR
REVISIONS:	-

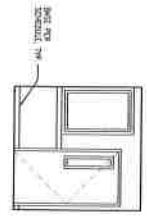


1 ARCTIC ENTRY - 114
A7.2 1/4" = 1'-0"

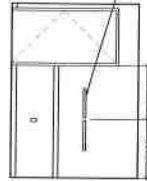




2 ARCTIC ENTRY - 114
A7.2 1/4" = 1'-0"

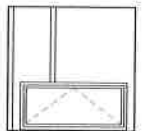


3 ARCTIC ENTRY - 114
A7.2 1/4" = 1'-0"

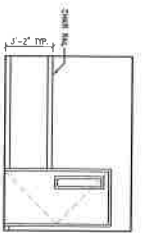


4 ARCTIC ENTRY - 114
A7.2 1/4" = 1'-0"

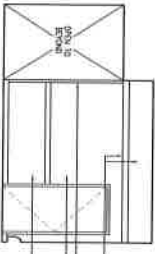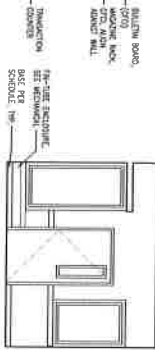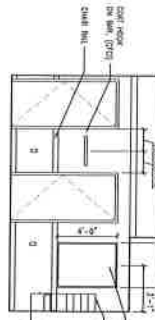



5 CLINIC WAITING - 110
A7.2 1/4" = 1'-0"

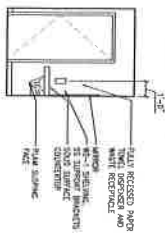


6 CLINIC WAITING - 110
A7.2 1/4" = 1'-0"

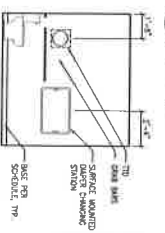


7 CLINIC WAITING - 110
A7.2 1/4" = 1'-0"

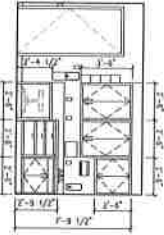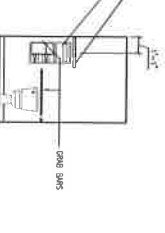


8 UNISEX TOILET - 109
A7.2 1/4" = 1'-0"

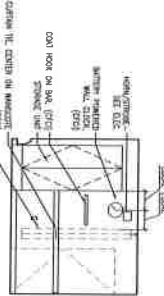

9 UNISEX TOILET - 109
A7.2 1/4" = 1'-0"

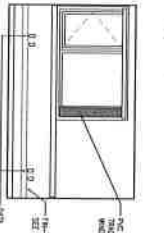

10 UNISEX TOILET - 109
A7.2 1/4" = 1'-0"

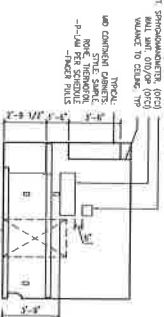





11 UNISEX TOILET - 109
A7.2 1/4" = 1'-0"

12 EXAM 2 - 108
A7.2 1/4" = 1'-0"

13 EXAM 2 - 108
A7.2 1/4" = 1'-0"

14 EXAM 2 - 108
A7.2 1/4" = 1'-0"

15 EXAM 2 - 108
A7.2 1/4" = 1'-0"

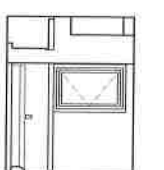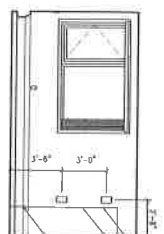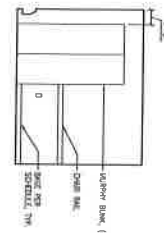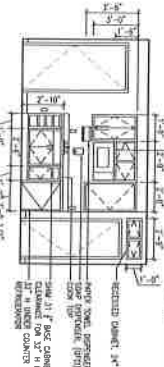

16 ITIN. QUAR/BEHV. HLTH. - 107
A7.2 1/4" = 1'-0"

17 ITIN. QUAR/BEHV. HLTH. - 107
A7.2 1/4" = 1'-0"

18 ITIN. QUAR/BEHV. HLTH. - 107
A7.2 1/4" = 1'-0"

19 ITIN. QUAR/BEHV. HLTH. - 107
A7.2 1/4" = 1'-0"

- GENERAL NOTES:
1. ALL DIMENSIONS SHOWN ARE TO FACE UNLESS NOTED OTHERWISE.
 2. ALL OPENING WALLS SHALL HAVE A MINIMUM (1) LAYER OF INSULATION.
 3. INSULATION SHALL BE 2" MINIMUM THICKNESS AND SHALL BE INSTALLED IN ACCORDANCE WITH THE MANUFACTURER'S INSTRUCTIONS.
 4. ALL INSULATION SHALL BE INSTALLED IN ACCORDANCE WITH THE MANUFACTURER'S INSTRUCTIONS.

NOT FOR CONSTRUCTION

PROJECT NO.	12-152
DATE	10 MAY 2013
DRAWN BY	KCS, JS
CHECKED BY	RM
REVISIONS	

95% DRAWINGS: NOT FOR CONSTRUCTION
12-152
TANANA CHIEFS CONFERENCE
RUBY CLINIC
RUBY, ALASKA



WATTERSON CONSTRUCTION
ph: (907)563-7441 fax: (907)563-7222

BETTISWORTH NORTH
ARCHITECTS AND PLANNERS

2000 DENALI STREET SUITE 710 ANCHORAGE, ALASKA 99503 907 561-5780
212 FRONT STREET FAIRBANKS, ALASKA 99701 907 456-5780
WWW.BETTISWORTHNORTH.COM

IF THIS DIMENSION DOES NOT MEASURE ONE INCH (1") EXACTLY, THIS DRAWING
HAS BEEN ENLARGED OR REDUCED, AFFECTING ALL LABELED SCALES

1" = 1'-0"

ARCTIC ENTRY - 105

ARCTIC ENTRY - 105

ARCTIC ENTRY - 105

ARCTIC ENTRY - 105

HALLWAY - 106

HALLWAY - 106

HALLWAY - 106

LAB - 116

LAB - 116

TYPICAL MOUNTING HEIGHTS



GENERAL NOTES:

1. ALL SPEC'D GROUT WALL BOARD SURFACES TO BE 2"X12".
2. ALL SPEC'D GROUT WALL BOARD SURFACES TO BE 2"X12".
3. 1"X12" GROUT WALL BOARD TO BE INSTALLED AT 16" O.C.
4. 1"X12" GROUT WALL BOARD TO BE INSTALLED AT 16" O.C.
5. 1"X12" GROUT WALL BOARD TO BE INSTALLED AT 16" O.C.

ROOM FINISH SCHEDULE REMARKS:

1. 1"X12" GROUT WALL BOARD TO BE INSTALLED AT 16" O.C.
2. 1"X12" GROUT WALL BOARD TO BE INSTALLED AT 16" O.C.
3. 1"X12" GROUT WALL BOARD TO BE INSTALLED AT 16" O.C.
4. 1"X12" GROUT WALL BOARD TO BE INSTALLED AT 16" O.C.
5. 1"X12" GROUT WALL BOARD TO BE INSTALLED AT 16" O.C.

ABBREVIATIONS:

- 1. 1"X12" GROUT WALL BOARD TO BE INSTALLED AT 16" O.C.
- 2. 1"X12" GROUT WALL BOARD TO BE INSTALLED AT 16" O.C.
- 3. 1"X12" GROUT WALL BOARD TO BE INSTALLED AT 16" O.C.
- 4. 1"X12" GROUT WALL BOARD TO BE INSTALLED AT 16" O.C.
- 5. 1"X12" GROUT WALL BOARD TO BE INSTALLED AT 16" O.C.

NOT FOR CONSTRUCTION

PROJECT NO: 12-152
DATE: 10 MAY 2013
DRAWN BY: MG, JS
CHECKED BY: RR
REVISIONS:

95% DRAWINGS: NOT FOR CONSTRUCTION
12-152
TANANA CHIEFS CONFERENCE
RUBY CLINIC
RUBY, ALASKA



WATERSON CONSTRUCTION
ph: (907)263-3441 fax: (907)263-7222
BETTISWORTH NORTH
ARCHITECTS AND PLANNERS
210 FRONT STREET, FAIRBANKS, ALASKA 99701
WWW.BETTISWORTHNORTH.COM

RM NO	RM NAME
-------	---------

Door No	Door Size	Door Type	Color Material	Frame Material	Color	Head Detail	Joint Detail	Slip Detail	Handle Type	Remarks
101	3'-0" x 7'-0"	F	W0	W0	P-2	-	-	-	3	1
102	3'-0" x 7'-0"	F	W0	W0	P-2	-	-	-	3	1
103	3'-0" x 7'-0"	F	W0	W0	P-2	-	-	-	4	1
104	3'-0" x 7'-0"	F	W0	W0	P-2	-	-	-	4	1
105	3'-0" x 7'-0"	F	W0	W0	P-2	-	-	-	4	1
106	3'-0" x 7'-0"	F	W0	W0	P-2	-	-	-	4	1
107	3'-0" x 7'-0"	F	W0	W0	P-2	-	-	-	4	1
108	3'-0" x 7'-0"	F	W0	W0	P-2	-	-	-	4	1
109	3'-0" x 7'-0"	F	W0	W0	P-2	-	-	-	4	1
110	3'-0" x 7'-0"	F	W0	W0	P-2	-	-	-	4	1
111	3'-0" x 7'-0"	F	W0	W0	P-2	-	-	-	4	1
112	3'-0" x 7'-0"	F	W0	W0	P-2	-	-	-	4	1
113	3'-0" x 7'-0"	F	W0	W0	P-2	-	-	-	4	1
114	3'-0" x 7'-0"	F	W0	W0	P-2	-	-	-	4	1
115	3'-0" x 7'-0"	F	W0	W0	P-2	-	-	-	4	1
116	3'-0" x 7'-0"	F	W0	W0	P-2	-	-	-	4	1
117	3'-0" x 7'-0"	F	W0	W0	P-2	-	-	-	4	1
118	3'-0" x 7'-0"	F	W0	W0	P-2	-	-	-	4	1
119	3'-0" x 7'-0"	F	W0	W0	P-2	-	-	-	4	1
120	3'-0" x 7'-0"	F	W0	W0	P-2	-	-	-	4	1
121	3'-0" x 7'-0"	F	W0	W0	P-2	-	-	-	4	1
122	3'-0" x 7'-0"	F	W0	W0	P-2	-	-	-	4	1
123	3'-0" x 7'-0"	F	W0	W0	P-2	-	-	-	4	1
124	3'-0" x 7'-0"	F	W0	W0	P-2	-	-	-	4	1
125	3'-0" x 7'-0"	F	W0	W0	P-2	-	-	-	4	1
126	3'-0" x 7'-0"	F	W0	W0	P-2	-	-	-	4	1
127	3'-0" x 7'-0"	F	W0	W0	P-2	-	-	-	4	1
128	3'-0" x 7'-0"	F	W0	W0	P-2	-	-	-	4	1
129	3'-0" x 7'-0"	F	W0	W0	P-2	-	-	-	4	1
130	3'-0" x 7'-0"	F	W0	W0	P-2	-	-	-	4	1
131	3'-0" x 7'-0"	F	W0	W0	P-2	-	-	-	4	1
132	3'-0" x 7'-0"	F	W0	W0	P-2	-	-	-	4	1
133	3'-0" x 7'-0"	F	W0	W0	P-2	-	-	-	4	1
134	3'-0" x 7'-0"	F	W0	W0	P-2	-	-	-	4	1
135	3'-0" x 7'-0"	F	W0	W0	P-2	-	-	-	4	1
136	3'-0" x 7'-0"	F	W0	W0	P-2	-	-	-	4	1
137	3'-0" x 7'-0"	F	W0	W0	P-2	-	-	-	4	1
138	3'-0" x 7'-0"	F	W0	W0	P-2	-	-	-	4	1
139	3'-0" x 7'-0"	F	W0	W0	P-2	-	-	-	4	1
140	3'-0" x 7'-0"	F	W0	W0	P-2	-	-	-	4	1
141	3'-0" x 7'-0"	F	W0	W0	P-2	-	-	-	4	1
142	3'-0" x 7'-0"	F	W0	W0	P-2	-	-	-	4	1
143	3'-0" x 7'-0"	F	W0	W0	P-2	-	-	-	4	1
144	3'-0" x 7'-0"	F	W0	W0	P-2	-	-	-	4	1
145	3'-0" x 7'-0"	F	W0	W0	P-2	-	-	-	4	1
146	3'-0" x 7'-0"	F	W0	W0	P-2	-	-	-	4	1
147	3'-0" x 7'-0"	F	W0	W0	P-2	-	-	-	4	1
148	3'-0" x 7'-0"	F	W0	W0	P-2	-	-	-	4	1
149	3'-0" x 7'-0"	F	W0	W0	P-2	-	-	-	4	1
150	3'-0" x 7'-0"	F	W0	W0	P-2	-	-	-	4	1

- ALL DOGS FROM
AND PARTS.

STYLING: M. WILSON
CLOTHING: J. WILSON

ROOM FINISH SCHEDULE REMARKS:

2. OTHER QUARTS DETECTED AT OTHER SITES

STYLE	COLOR
-------	-------

[illegible]

ES: NOT FOR CONSTRUCTION

ES CONFERENCE

CLINIC


JHEP07(2016)189

CONSULTANT:
95% DRAWING
12-152
TANANA CHIL
RUBY C
RUBY, ALASKA

See South.

PROJECT NO: 12-152
DATE: 10 MAY 2013
DRAWN BY: MG, JS
CHECKED BY: RR
REVISIONS: -

1
1

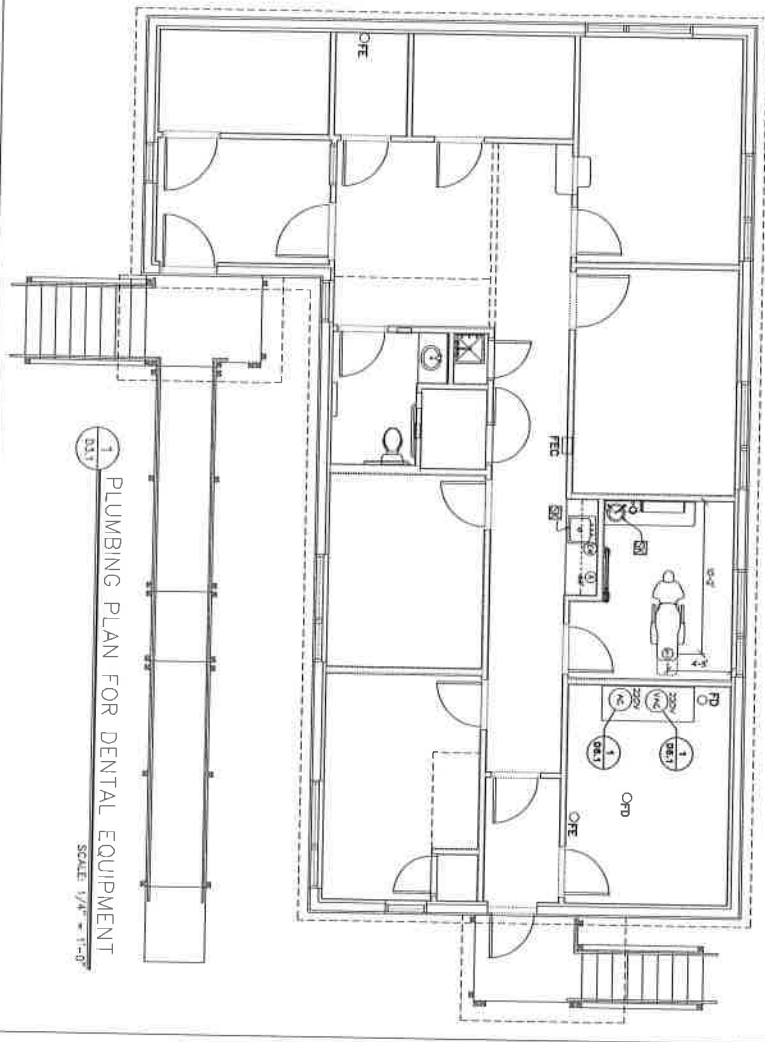

1 PLUMBING PLAN FOR DENTAL EQUIPMENT
SCALE 1/4" = 1'-0"

BURKHART
DENTAL SUPPLY COMPANY
2502 South 28th Street
Anchorage, Alaska 99509
12000 Industrial Way, Unit 11-1
Anchorage, Alaska 99515
Phone: 1-866-334-1883
Fax: 1-253-212-4981

NOTE:
All plumbing, heating, and cooling lines, including piping, vent lines and other lines, shall be installed in accordance with the applicable codes and standards. The contractor shall be responsible for obtaining all necessary permits and for ensuring that all work is done in accordance with the applicable codes and standards. The contractor shall also be responsible for ensuring that all work is done in a timely and efficient manner. The contractor shall also be responsible for ensuring that all work is done in a safe and sound manner. The contractor shall also be responsible for ensuring that all work is done in a professional and courteous manner. The contractor shall also be responsible for ensuring that all work is done in a clean and organized manner. The contractor shall also be responsible for ensuring that all work is done in a safe and sound manner. The contractor shall also be responsible for ensuring that all work is done in a professional and courteous manner. The contractor shall also be responsible for ensuring that all work is done in a clean and organized manner.

8 SPECIFICATIONS FOR THE DENTAL EQUIPMENT ONLY:

PLUMBING LEGEND
ALL ITEMS NOT MARKED WITH A CHECK ARE NOT APPLICABLE TO THIS JOB

1. Radiant heating/cooling system. The system shall be installed in accordance with the applicable codes and standards. The contractor shall be responsible for ensuring that all work is done in a timely and efficient manner. The contractor shall also be responsible for ensuring that all work is done in a safe and sound manner. The contractor shall also be responsible for ensuring that all work is done in a professional and courteous manner. The contractor shall also be responsible for ensuring that all work is done in a clean and organized manner.
2. The contractor shall be responsible for ensuring that all work is done in a timely and efficient manner. The contractor shall also be responsible for ensuring that all work is done in a safe and sound manner. The contractor shall also be responsible for ensuring that all work is done in a professional and courteous manner. The contractor shall also be responsible for ensuring that all work is done in a clean and organized manner.
3. The contractor shall be responsible for ensuring that all work is done in a timely and efficient manner. The contractor shall also be responsible for ensuring that all work is done in a safe and sound manner. The contractor shall also be responsible for ensuring that all work is done in a professional and courteous manner. The contractor shall also be responsible for ensuring that all work is done in a clean and organized manner.
4. The contractor shall be responsible for ensuring that all work is done in a timely and efficient manner. The contractor shall also be responsible for ensuring that all work is done in a safe and sound manner. The contractor shall also be responsible for ensuring that all work is done in a professional and courteous manner. The contractor shall also be responsible for ensuring that all work is done in a clean and organized manner.
5. The contractor shall be responsible for ensuring that all work is done in a timely and efficient manner. The contractor shall also be responsible for ensuring that all work is done in a safe and sound manner. The contractor shall also be responsible for ensuring that all work is done in a professional and courteous manner. The contractor shall also be responsible for ensuring that all work is done in a clean and organized manner.
6. The contractor shall be responsible for ensuring that all work is done in a timely and efficient manner. The contractor shall also be responsible for ensuring that all work is done in a safe and sound manner. The contractor shall also be responsible for ensuring that all work is done in a professional and courteous manner. The contractor shall also be responsible for ensuring that all work is done in a clean and organized manner.
7. The contractor shall be responsible for ensuring that all work is done in a timely and efficient manner. The contractor shall also be responsible for ensuring that all work is done in a safe and sound manner. The contractor shall also be responsible for ensuring that all work is done in a professional and courteous manner. The contractor shall also be responsible for ensuring that all work is done in a clean and organized manner.
8. The contractor shall be responsible for ensuring that all work is done in a timely and efficient manner. The contractor shall also be responsible for ensuring that all work is done in a safe and sound manner. The contractor shall also be responsible for ensuring that all work is done in a professional and courteous manner. The contractor shall also be responsible for ensuring that all work is done in a clean and organized manner.
9. The contractor shall be responsible for ensuring that all work is done in a timely and efficient manner. The contractor shall also be responsible for ensuring that all work is done in a safe and sound manner. The contractor shall also be responsible for ensuring that all work is done in a professional and courteous manner. The contractor shall also be responsible for ensuring that all work is done in a clean and organized manner.
10. The contractor shall be responsible for ensuring that all work is done in a timely and efficient manner. The contractor shall also be responsible for ensuring that all work is done in a safe and sound manner. The contractor shall also be responsible for ensuring that all work is done in a professional and courteous manner. The contractor shall also be responsible for ensuring that all work is done in a clean and organized manner.

PLUMBING TOLERANCES FOR CONDUIT
Tolerances shall be in accordance with the applicable codes and standards. The contractor shall be responsible for ensuring that all work is done in a timely and efficient manner. The contractor shall also be responsible for ensuring that all work is done in a safe and sound manner. The contractor shall also be responsible for ensuring that all work is done in a professional and courteous manner. The contractor shall also be responsible for ensuring that all work is done in a clean and organized manner.

PLUMBING PLAN
Sheet 3 of 6
D3.1

PROJECT NO.: 12-152
DATE: 14 JUNE 2013
DRAWN BY: JS
CHECKED BY: RR
REVISIONS:

100% CONSTRUCTION DRAWINGS
12-152
TANANA CHIEFS CONFERENCE
RUBY CLINIC
RUBY, ALASKA

WATTESON CONSTRUCTION
PH: (907) 263-7441 FAX: (907) 263-7222
BETTISWORTH NORTH
ARCHITECTS AND PLANNERS
3600 DENALI STREET SUITE 110 ANCHORAGE, ALASKA 99503
300 FRONT STREET EAST KENAI, ALASKA 99550
WWW.BETTISWORTHNORTH.COM